

CORE 2

CORE 3

LEGEND


- IONISATION SMOKE DETECTOR
- OPTICAL SMOKE DETECTOR

CORE 1

CORE 4

CORE 8

CORE 5

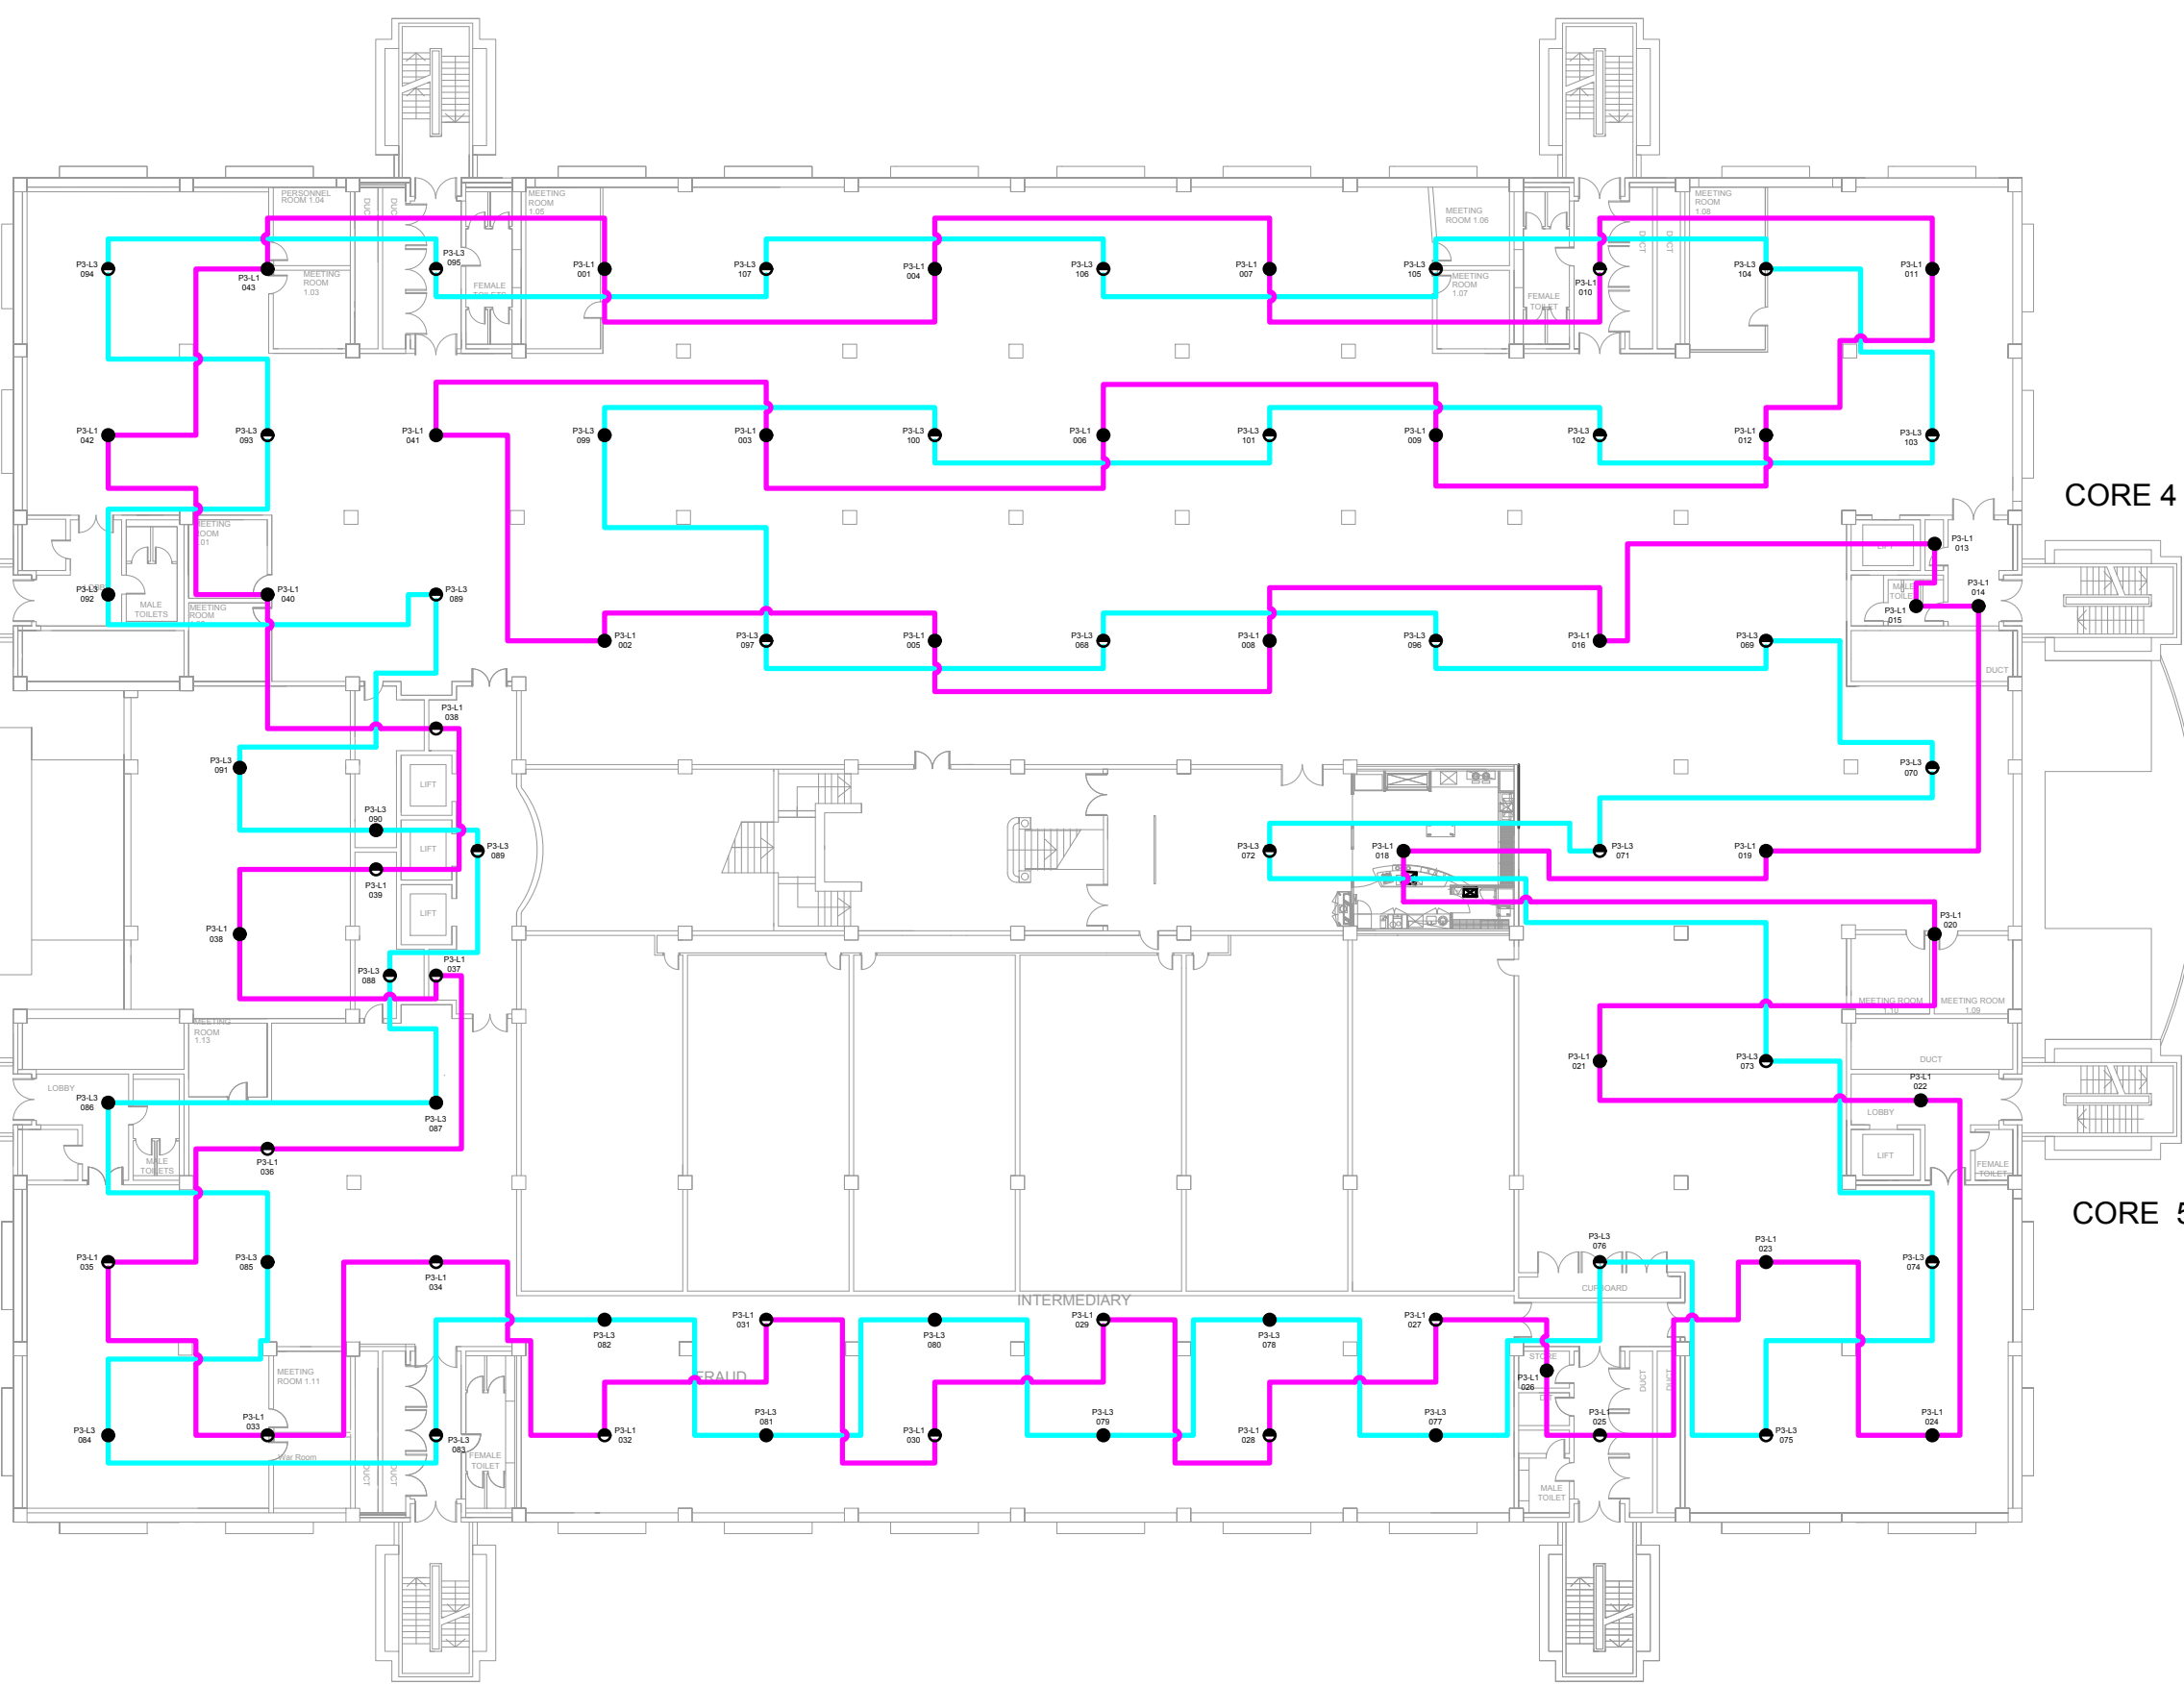

First Floor

CORE 7

CORE 6

REVISIONS



Cinnabar
 8 : White St : Kibworth Beauchamp :
 Leicestershire : LE8 0JG
 E : theoffice@cinnabar-cad.co.uk
 W : www.cinnabar-cad.co.uk
 T : 0116 2796605 M : 07808 732119

CLIENT: A CLIENT	
BUILDING: A BUILDING AN ADDRESS AN ADDRESS A COUNTY AB1 2CD	
FLOOR: A FLOOR	
DRAWING TITLE: AS INSTALLED FIRE ALARM SYSTEM ABOVE CEILING LEVEL EXAMPLE DRAWING	
SCALE @ 1:1, A1: NTS	DATE:
DRAWN: G.R.W	CHECKED: PROJECT NO:
DRAWING NO:	REV: