

CORE 2

CORE 3

CORE 1

CORE 4

CORE 8








CORE 5


First Floor

CORE 7

CORE 6

**LEGEND**

-  IONISATION SMOKE DETECTOR
-  OPTICAL SMOKE DETECTOR
-  RATE-OF-RISE HEAT DETECTOR
-  DETECTOR MODULE
-  RELAY MODULE
-  MANUAL CALL POINT
-  SOUNDER

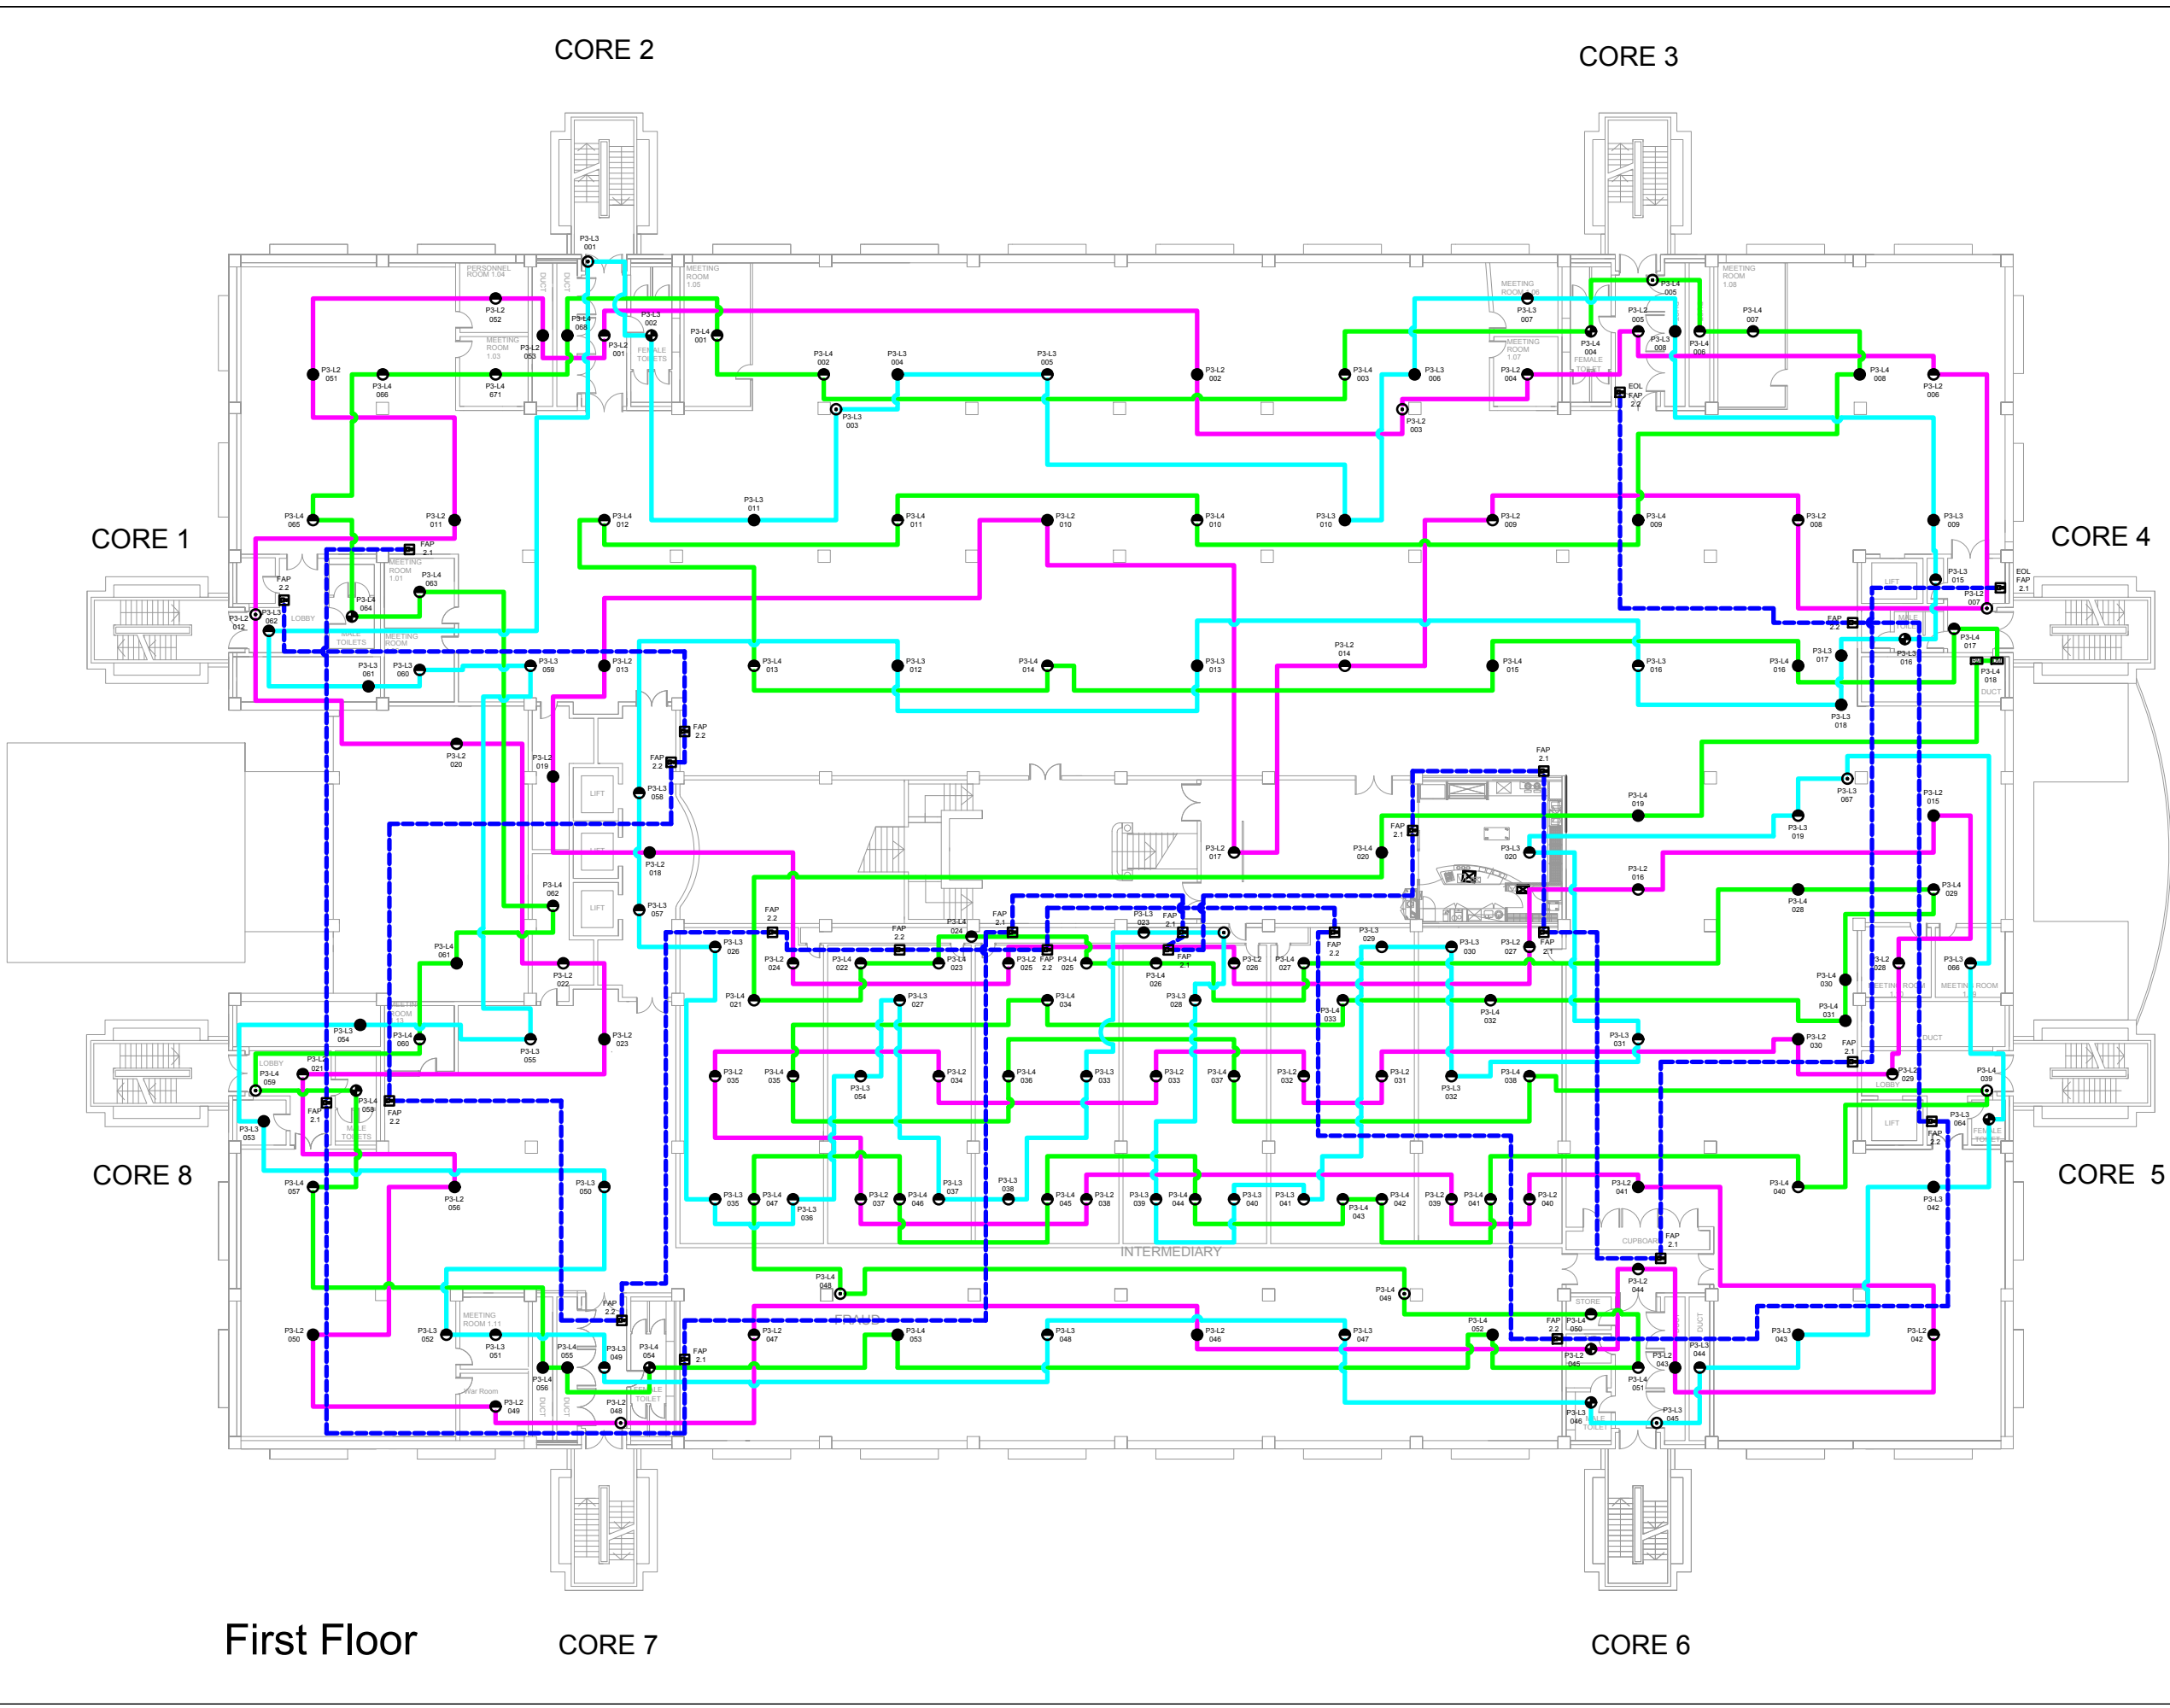

REVISIONS



**Cinnabar**  
 8 : White St : Kibworth Beauchamp :  
 Leicestershire : LE8 0JG  
 E : theoffice@cinnabar-cad.co.uk  
 W : www.cinnabar-cad.co.uk  
 T : 0116 2796605 M : 07808 732119

CLIENT: <b>A CLIENT</b>		
BUILDING: A BUILDING AN ADDRESS A COUNTY AB1 2CD		
FLOOR: A FLOOR		
DRAWING TITLE: AS INSTALLED FIRE ALARM SYSTEM AT CEILING LEVEL EXAMPLE DRAWING		
SCALE @ 1:1, A1: <b>NTS</b>	DATE:	
DRAWN: <b>G.R.W</b>	CHECKED:	PROJECT NO.:
DRAWING NO.:	REV:	